


revisions

3660 embassy parkway
akron, ohio 44333
tel. 330 . 666 . 5770
fax. 330 . 666 . 8812
www.mann-architects.com

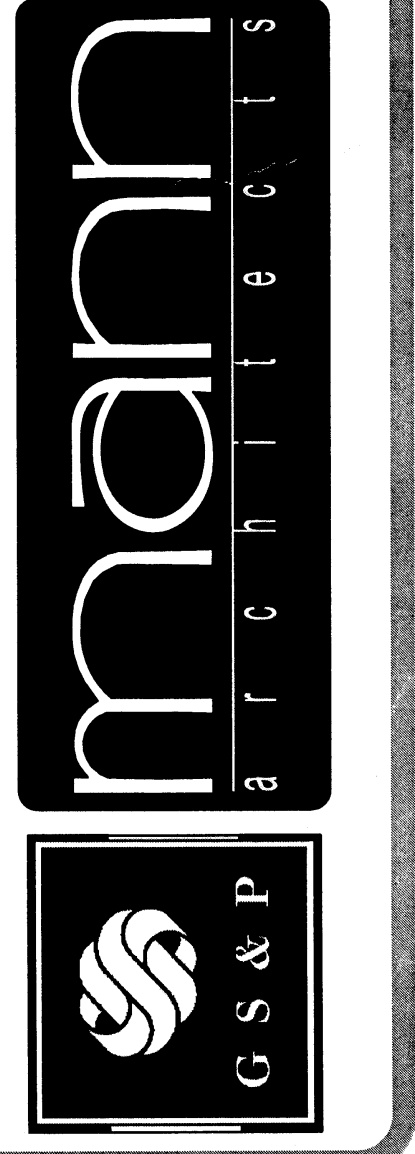


drawing
LIGHTING PLAN - WEST
project no. 11406
date OCTOBER 23, 2007
scale AS NOTED
AS NOTED

COLUMBUS ONCOLOGY
JASONWAY PROFESSIONAL BUILDING
810 JASONWAY AVENUE SUITE A
COLUMBUS, OHIO 43214-2379


E2.1
sheet no.

LIGHTING FIXTURE SCHEDULE			
TYPE	WATTAGE LAMP	DESCRIPTION	CATALOG NUMBER
A	3-32W T-8	FLUOR, 2x4, RECESSED, INDIRECT, PERF BASKET	COLUMBIA STR24-332G-MPO-E-120
A2	3-32W T-8	FLUOR, 2x4, RECESSED, INDIRECT, PERF BASKET, 2 BALLASTS	COLUMBIA STR24-332G-MPO-2E-120
B	4-32W	FLUOR, 2x4, RECESSED, PRISMATIC	COLUMBIA JTB-24-432-G-FS-A12-E120
C	3-32W	FLUOR, 2x4, RECESSED, PRISMATIC	COLUMBIA JTB-24-332-G-FS-A12-E120
D	2-32W	FLUOR, 1x4, SURFACE WRAP	COLUMBIA AWN-232-E-120
F	42W	COMPACT FLUOR, RECESSED, HORIZONTAL LAMP	PRESCOLITE LF6CFH132EB-WB
F2	26W	COMPACT FLUOR, RECESSED, HORIZONTAL LAMP	PRESCOLITE LF6CFH132EB-WB
G	70W	METAL HALIDE FLOOD	HUBBELL MIC-0070H-358
H	2-40W BIAx	FLUOR, 2x2, RECESSED INDIRECT, PERF BASKET	COLUMBIA STR-22-240TT-G-MPO-E-120
K	60w MINI	PENDANT, 120V MONOPT	TECH LTG 700-R-W-MONOPT
M		FLUOR, WALL	PROGRESS P7114-60EB
N	32W	COMPACT FLUOR, RECESSED	PRESCOLITE LF6CFH132EB-WB
P	150W	METAL HALIDE, RECESSED, U.L DAMP. (CANOPY)	PRESCOLITE LFBMH-8MHU
P2	70W	METAL HALIDE, RECESSED, U.L DAMP. (CANOPY)	PRESCOLITE LFBMH-6MHU
R	3-40TT	FLUOR, 2x2, DIRECT/INDIRECT, PERF BASKET, 2 BALLASTS	COLUMBIA STR22-340TT-G-MPO-(2)EP-120
Q	70W	MEATAL HALIDE, WALL FIXT	DEVINE BWD15-70MH-120-DBZ
EA		EXIT SIGN W/ BATTERY	DUALLITE LXURWE
EB		BATTERY LIGHT	DUALITE CV2
EC		BATTERY LT, 2 INTEGRAL HEADS & 2 REMOTE HEADS	DUALLITE CV5-OMSDB

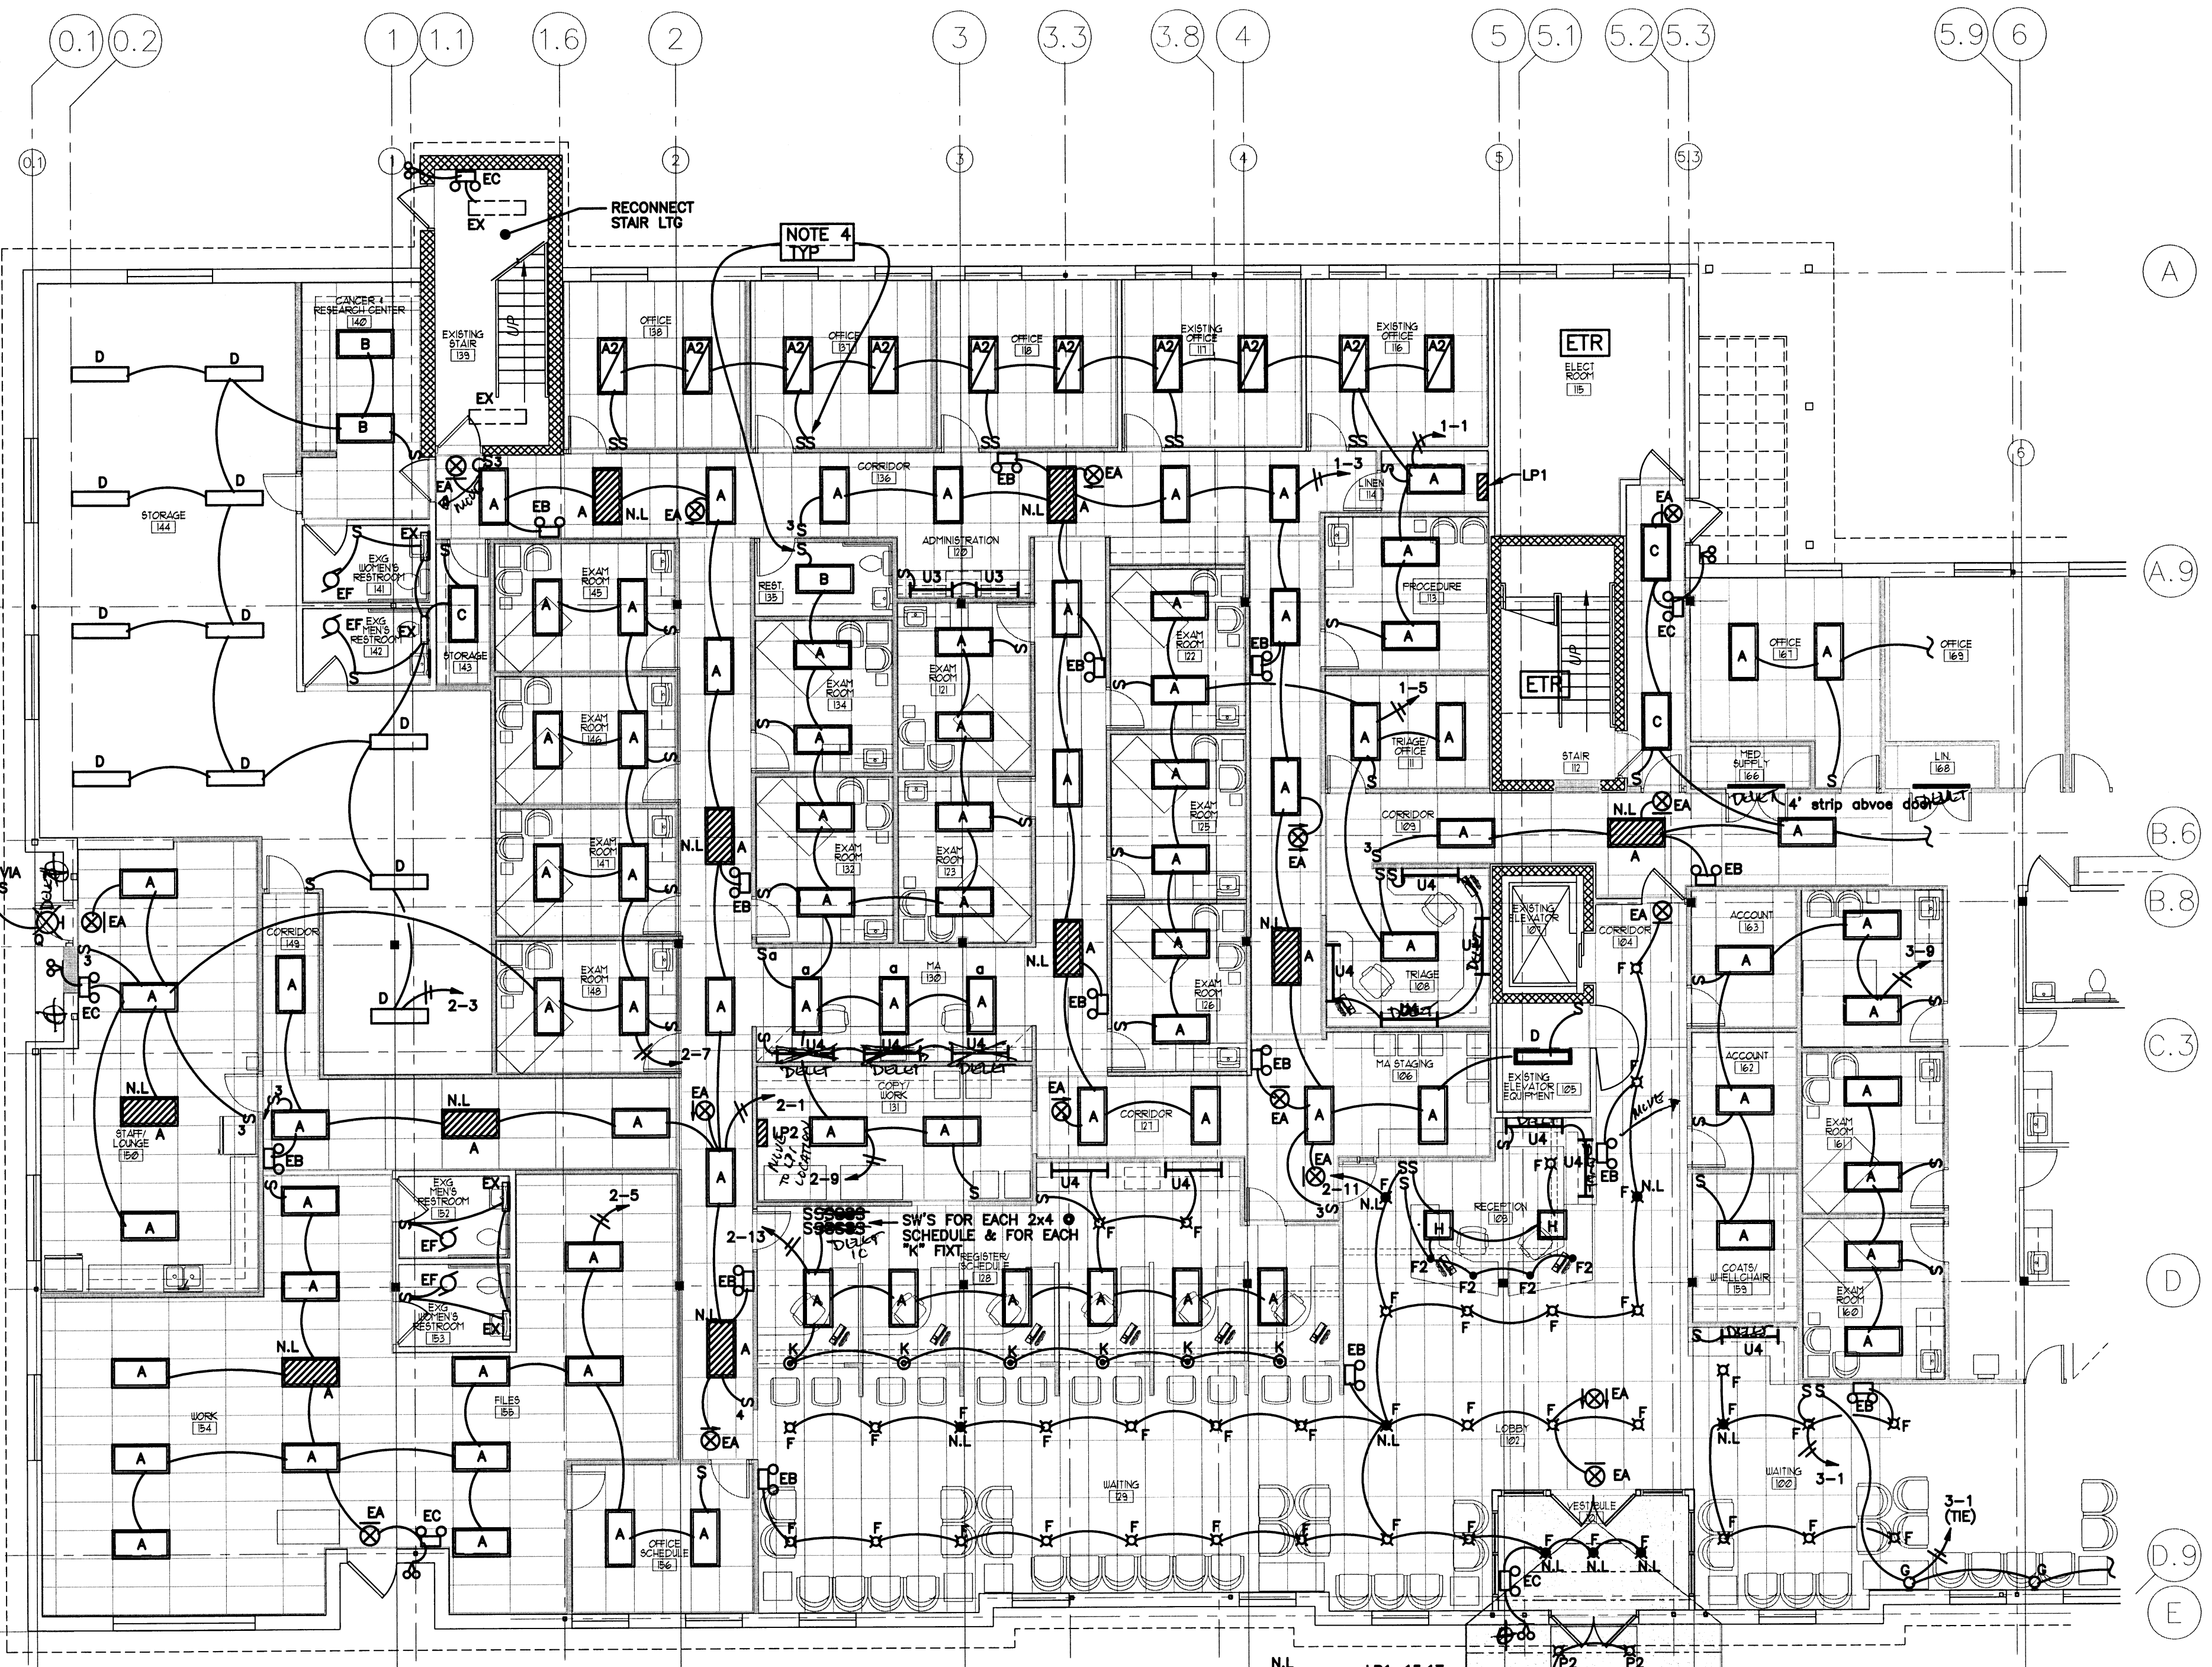

LIGHTING PLAN - WEST
SCALE: 1/8"=1'-0"

- NOTES**
- NIGHT LTS, EXITS & EMERG LTS SHALL BE CONNECTED AHEAD OF SWITCHES
 - CONNECT U.C LTG TO RECEPT CKT.
 - PROVIDE NEW PHOTOCELL FOR ALL EXTERIOR LTG. PROVIDE NEW 4P CONTACTOR, PHOTOCELL, ON @ DUSK, TIMECLOCK (EXIST) OFF @ 11:00PM (VERIFY)
 - ALL EXAM ROOMS, OFFICES, TOILETS, WORK ROOMS SHALL HAVE A WALL SWITCH OCCUPANCY SENSOR W/ OVER RIDE. PROVIDE POWER PACKS AS REQ'D. SIMILAR TO WATT STOPPER WS-200

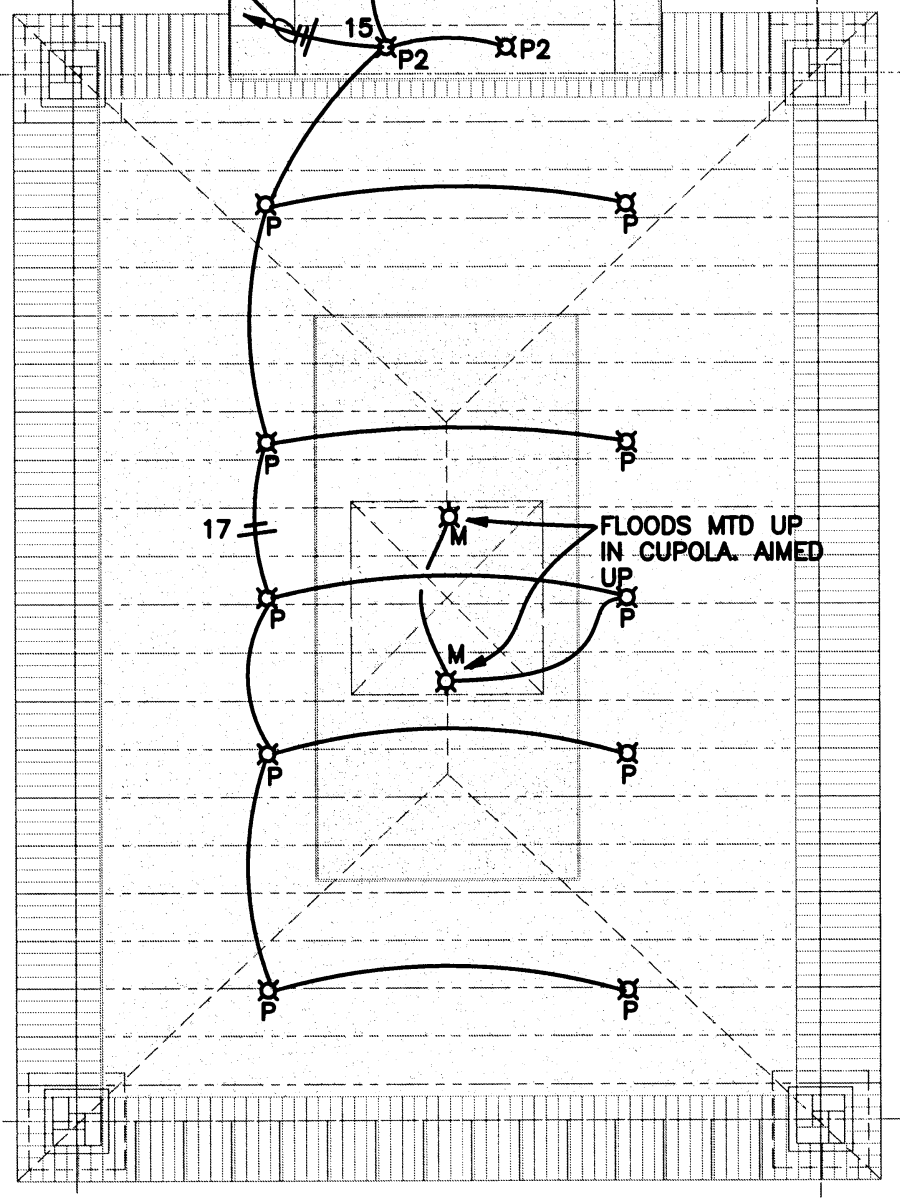

x:\projects\2007\11406 - Columbus Oncology\DWG Files\Electrical\10-23-07\E2.1.dwg, 10/22/2007 5:37:16 PM, MANN, DICKEY