


LIGHTING PLAN - EAST
SCALE: 1/8" = 1'-0"

- NOTES**
- NIGHT LTS, EXITS & EMERG LTS SHALL BE CONNECTED AHEAD OF SWITCHES
 - CONNECT U.C LTO TO RECEPT CKT.
 - ALL EXAM ROOMS, OFFICES, TOILETS, WORK ROOMS SHALL HAVE A WALL SWITCH OCCUPANCY SENSOR W/ OVER RIDE. PROVIDE POWER PACKS AS REQ'D. SIMILAR TO WATT STOPPER WS-200

revisions

3660 embassy parkway
akron, ohio 44333
tel. 330 . 666 . 5770
fax. 330 . 666 . 8812
www . mann-architects . com

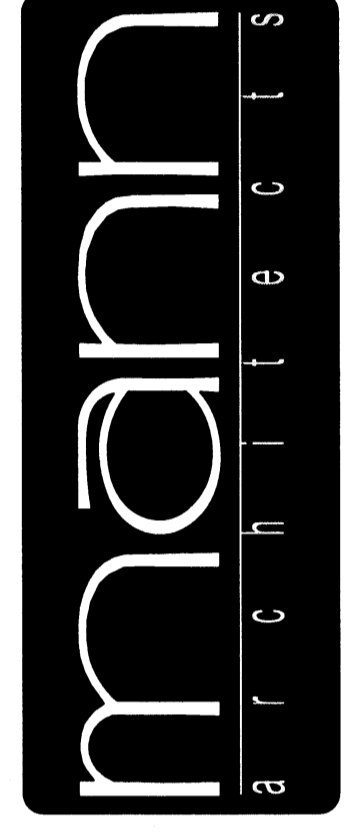

drawing
LIGHTING PLAN - EAST
project no. 11406
date OCTOBER 23, 2007
scale AS NOTED

COLUMBUS ONCOLOGY
JASONWAY PROFESSIONAL BUILDING
910 JASONWAY AVENUE SUITE A
COLUMBUS, OHIO 43214-2329

E2.2
sheet no.