
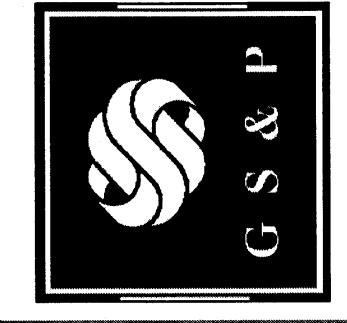


SECOND FLOOR LIGHTING PLAN
SCALE: 1/8"=1'-0"

NOTE: 2nd FL. IS PHASE 1.
TEMP CKTS MAY BE REQ'D.

revisions

3660 embassy parkway
akron, ohio 44333
tel. 330 . 666 . 5770
fax. 330 . 666 . 8812
www . mann-architects . com

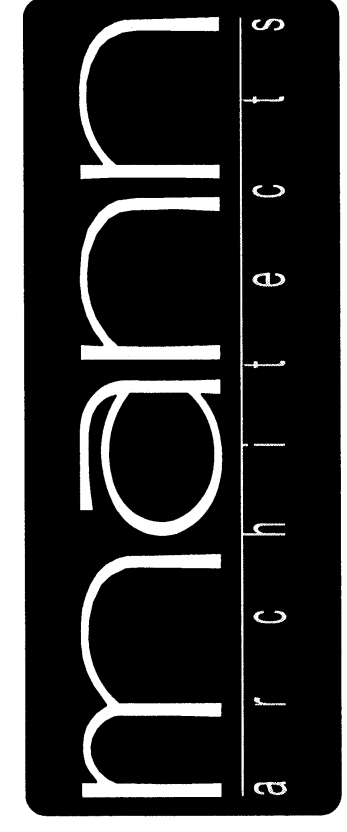

drawing
SECOND FLOOR LIGHTING PLAN scale AS NOTED
project no. 11406 date OCTOBER 23, 2007
COLUMBUS ONCOLOGY
JASONWAY PROFESSIONAL BUILDING
810 JASONWAY AVENUE, SUITE A
COLUMBUS, OHIO 43214-2325

E2.3
sheet no.