

DON'T USE FOR  
FIRE ALARM USE  
FIRE PRINT.


**SECOND FLOOR POWER PLAN**

SCALE: 1/8" = 1'-0"

**NOTES:**



1. REPLACE ALL FA DEVICES ON ENTIRE 2nd FL. W/ NEW & CONNECT TO NEW SYSTEM
2. APPROX 6 CKTS NOW FEED 2nd FL. ONCOLOGY AREA FROM EXIST PANEL TP1. TIE IN & REROUTE TO NEW PANEL LP1-27 THRU 37.

NOTE: 2nd FL. IS PHASE 1.  
TEMP CKTS MAY BE REQ'D.

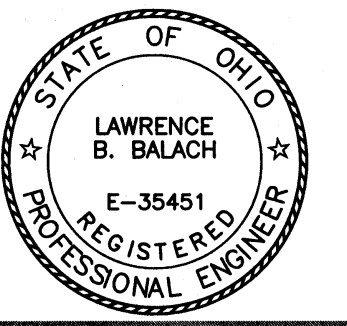

revisions


3660 embassy parkway  
akron, ohio 44333  
tel. 330 . 666 . 5770  
fax. 330 . 666 . 8812  
www . mann-architects . com

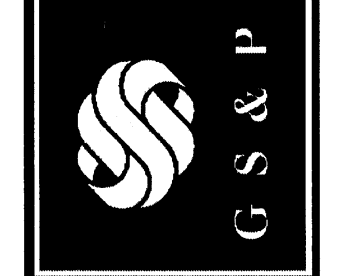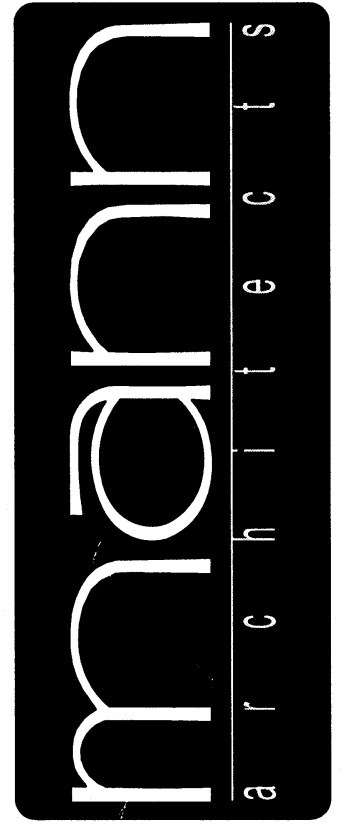

drawing

SECOND FLOOR POWER PLAN  
project no. 11406  
date OCTOBER 23, 2007  
scale AS NOTED

**COLUMBUS ONCOLOGY**  
JASONWAY PROFESSIONAL BUILDING  
810 JASONWAY AVENUE, SUITE A  
COLUMBUS, OHIO 43214-2329

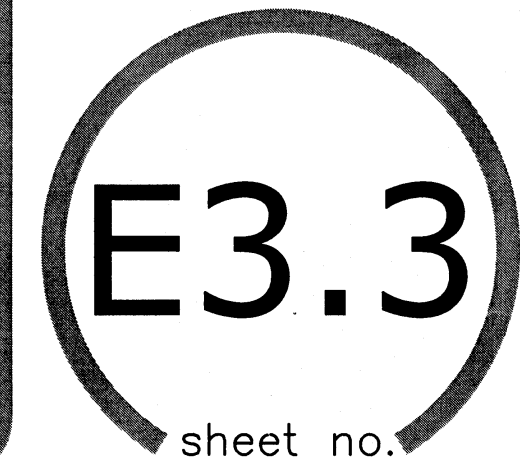

sheet no.